


Notes

1. This drawing is to be read in conjunction with all the relevant contract documentation.
2. All dimensions are in mm unless otherwise stated. Dimensions to be checked on site prior to construction and any discrepancies reported to the Rolton Group Engineer.
3. Only drawings that indicate CONSTRUCTION as the issue purpose should be used for construction.
4. Any CONSTRUCTION status issue does not provide or imply approval or validation of any third party information.
5. Revision clouds are shown for assistance only, the whole drawing is to be checked for new/ amended information.
6. Not all hatches and linetypes shown on legends and keys may be present on this drawing. Drawings to be printed in colour by default, typical material colours are for clarity only.
7. All services are new unless stated otherwise.

- Isolines**
- 0.1 lx
 - 0.2 lx
 - 0.5 lx
 - 1.0 lx
 - 2.0 lx
 - 5.0 lx
 - 10.0 lx
 - 20.0 lx
 - 50.0 lx
 - 100.0 lx

Saxon Street

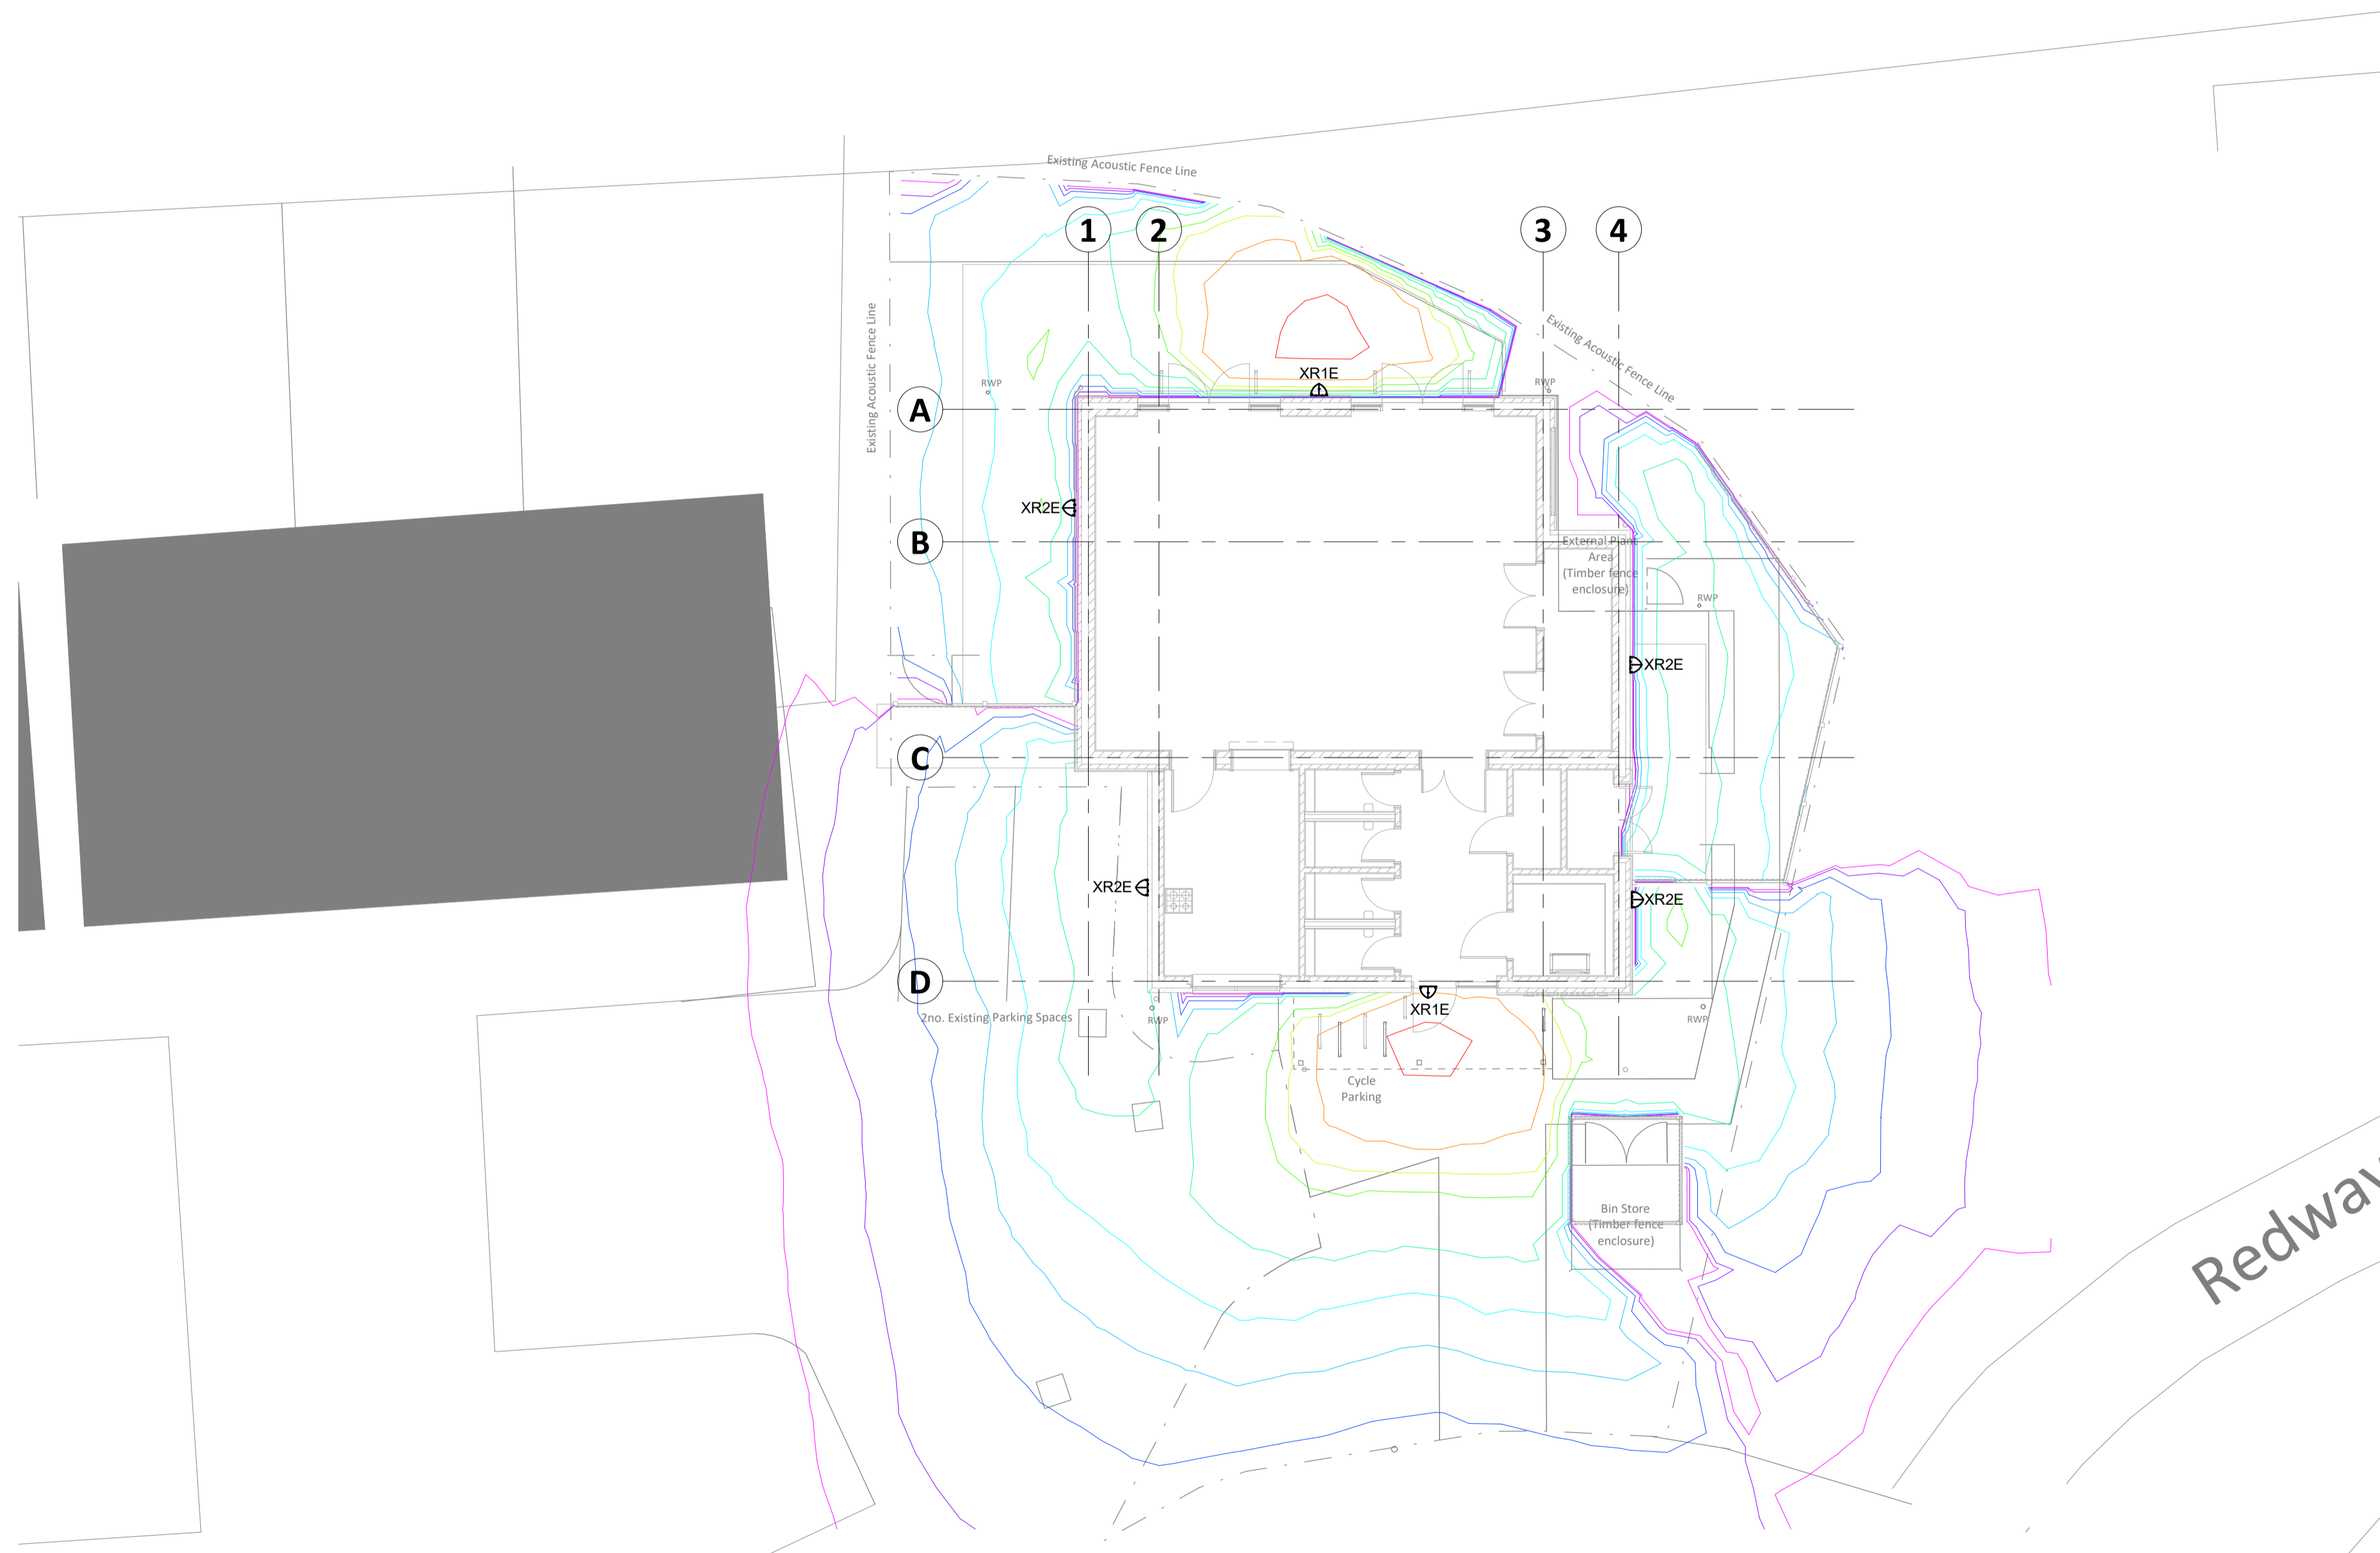

Thorlux REALTA

LUMINAIRE SCHEDULE	
REF.	DETAILS
XR1E	Thorlux REALTA AREA DISTRIBUTION Protection Ratings: IP66 Wattage: 20W Colour Temperature: 4000K Emergency: 3hr, Autotest
XR2E	Thorlux REALTA WIDE DISTRIBUTION Protection Ratings: IP66 Wattage: 8W Colour Temperature: 4000K Emergency: 3hr, Autotest

DO NOT SCALE Copyright Rolton Group Ltd 2021
This drawing shall remain the copyright of Rolton Group Ltd.

Standard construction hazards that a competent contractor would be aware of have not been identified on this drawing. Risks that may not be immediately apparent are listed below.

Status	Date	Description	Dwn	Eng	Chkd	Veri
S2-P01	25.01.21	Issued For Information	GZ	GZ	MS	MS
S2-P02	01.08.22	Issued For Information	CT	CT	CW	CW

This drawing and the information contained herein are indicative and to be used by the contractor to assess the scope of works relating. The responsibility for the design, coordination and installation remains with the contractor.



ROLTON GROUP
ENGINEERING THE FUTURE™
www.rolton.com 01933 410909

Project:
**Heelands Community Centre,
Milton Keynes - upto RIBA Stage
3 (Performance Design)**

Drawing title:
**Electrical Building Services
Street/ Area/ Flood Lighting
Site Plan**

RGL Project Ref: 20-0427 | Scale@A1: 1:100 | Scale@A3: 1:200
Specification(s):
200427-RGL-ZZ-XX-SP-U-0001

Drawing Number:
200427-RGL-ZZ-00-DR-E-91-0001
Project Originator-Zone-Level-Type-Role-Classification-Number
Issue Purpose:
INFORMATION Status:
S2-P02
Suitability-Revision